



Armitage Shanks Monaco Doc M Pack - White
Product Code: S7075AC

Includes:


- 1 x Raised height close coupled toilet pack with China cistern
- 1 x 450mm Straight white grab rail
- 4 x 600mm Straight white grab rail
- 1 x Hinged white grab rail
- 1 x Seat included with retaining buffers (no cover)
- 1 x Elongated cistern to achieve 75cm projection
- 1 x Single lever basin mixer tap - chrome

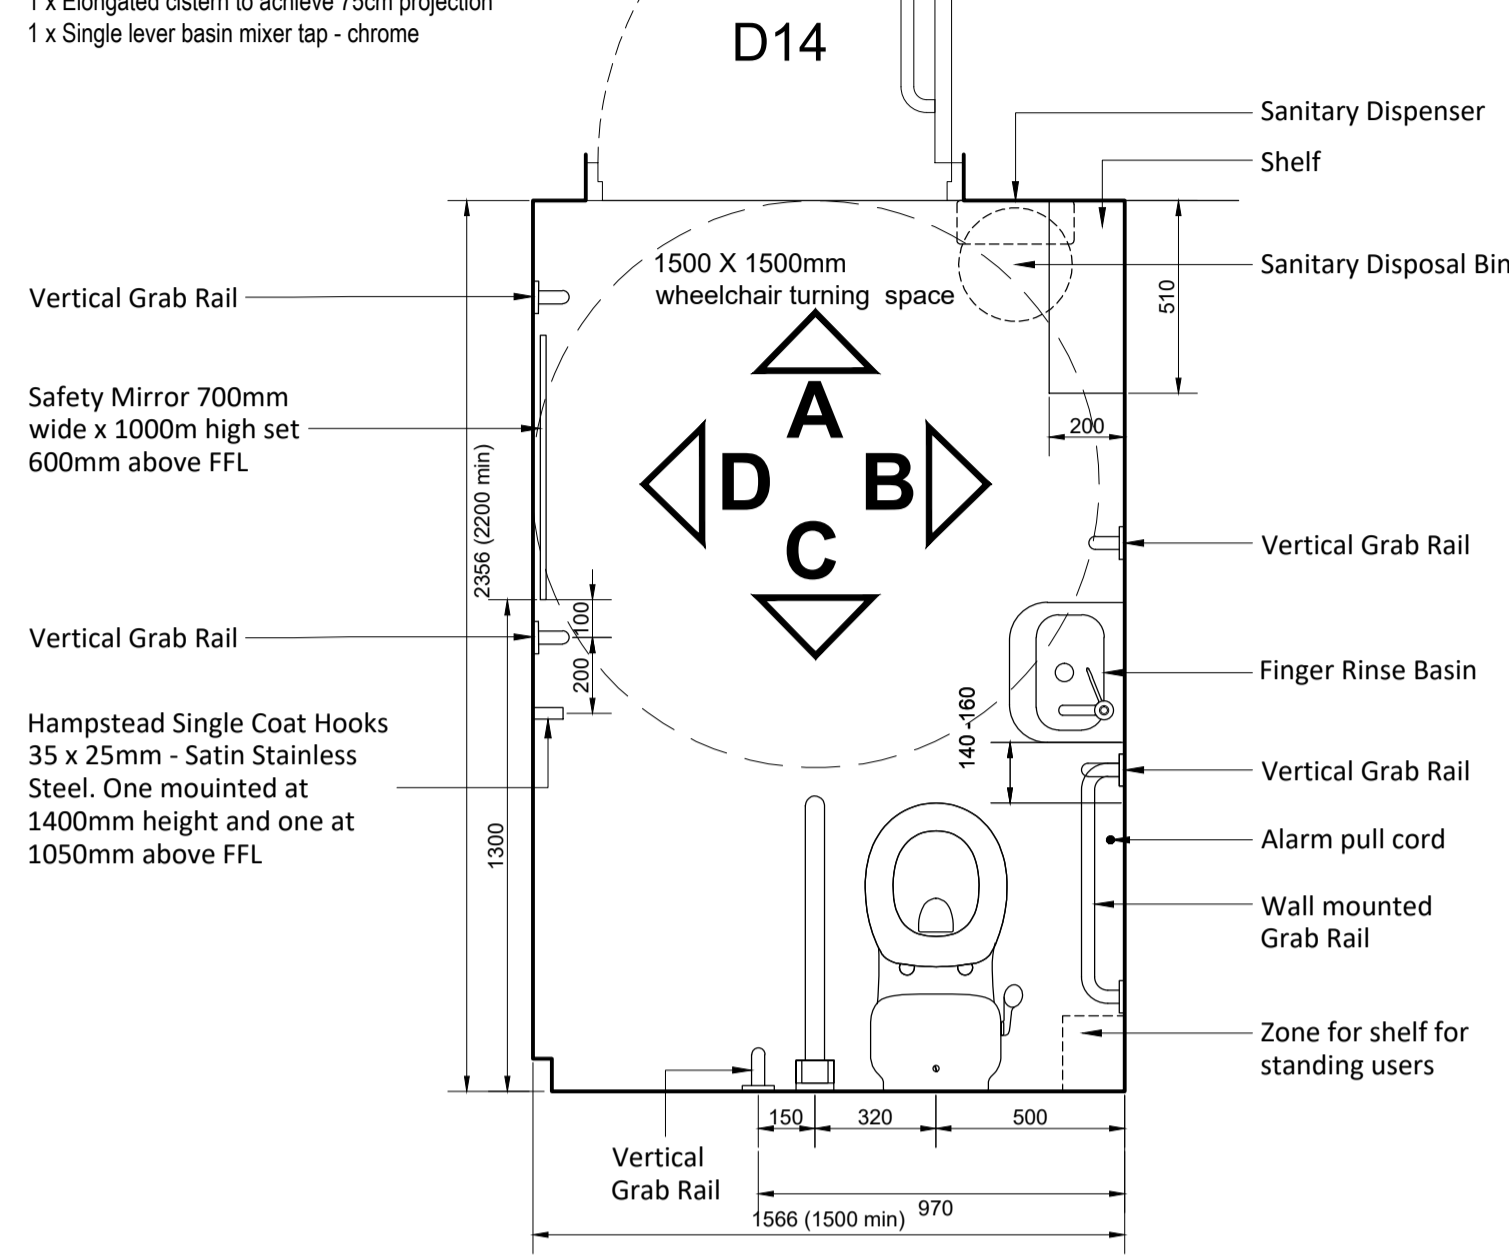


**G17 FLOOR PLAN
UNISEX ACCESSIBLE TOILET**

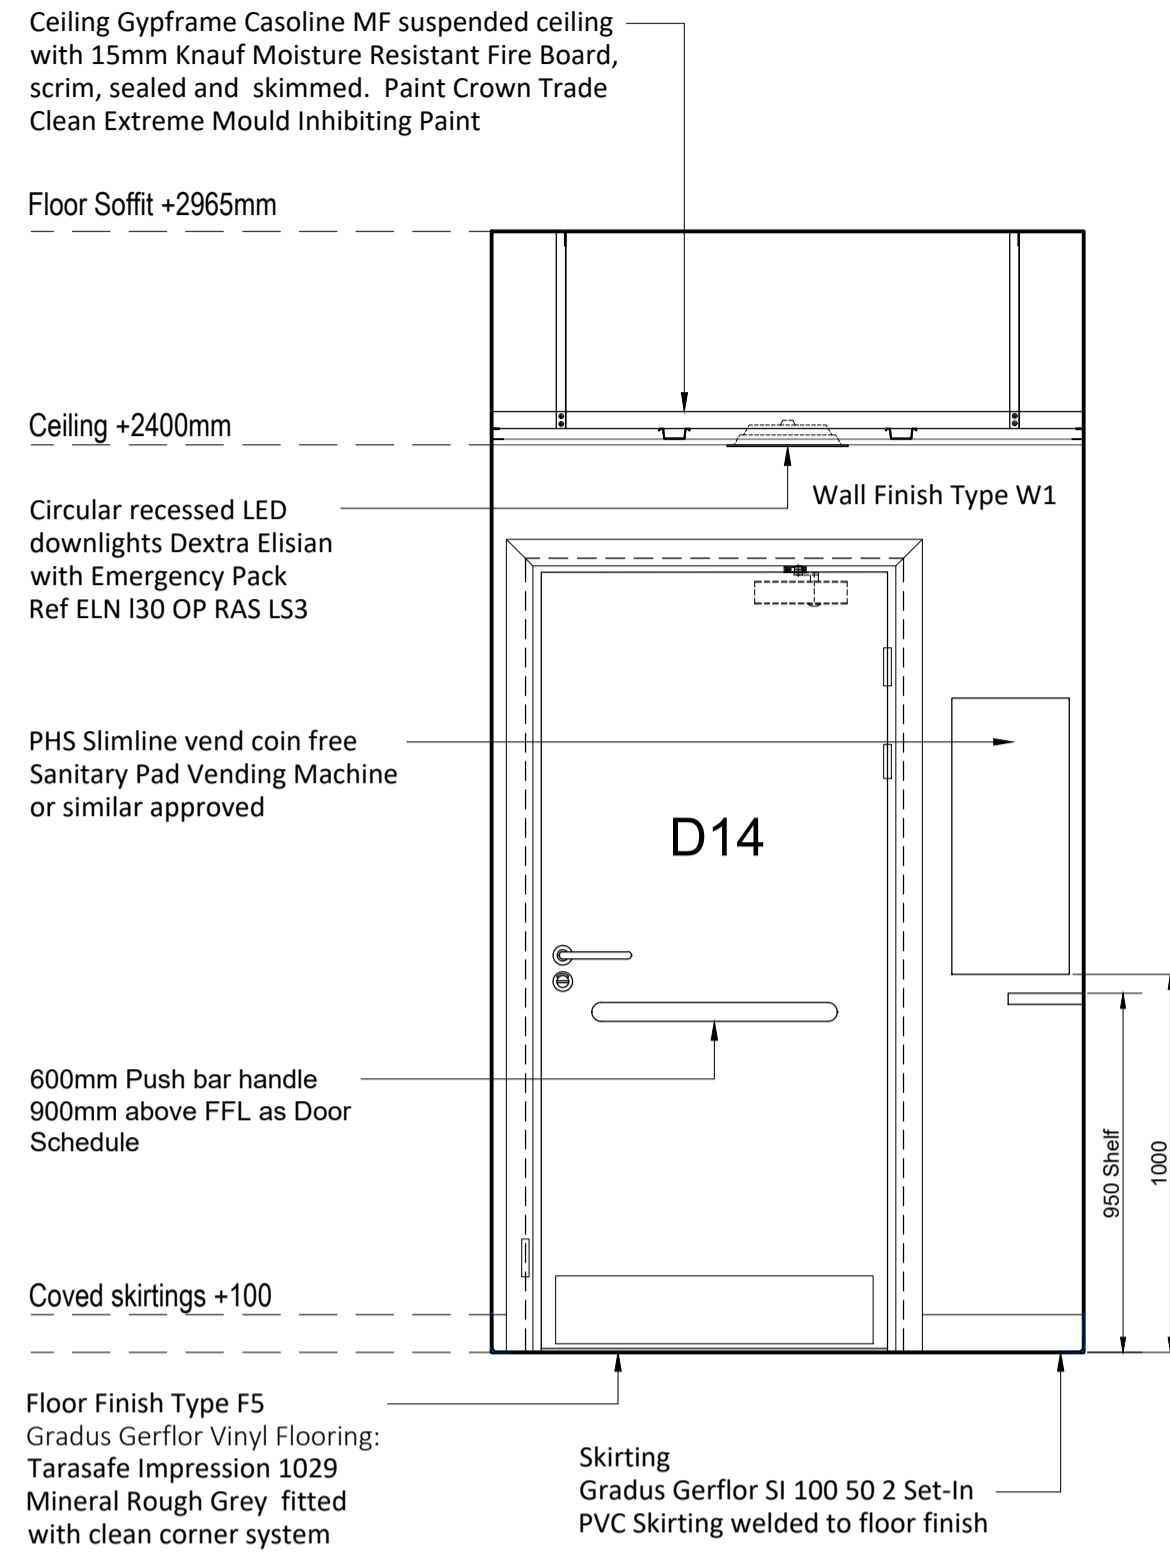


ELEVATION A

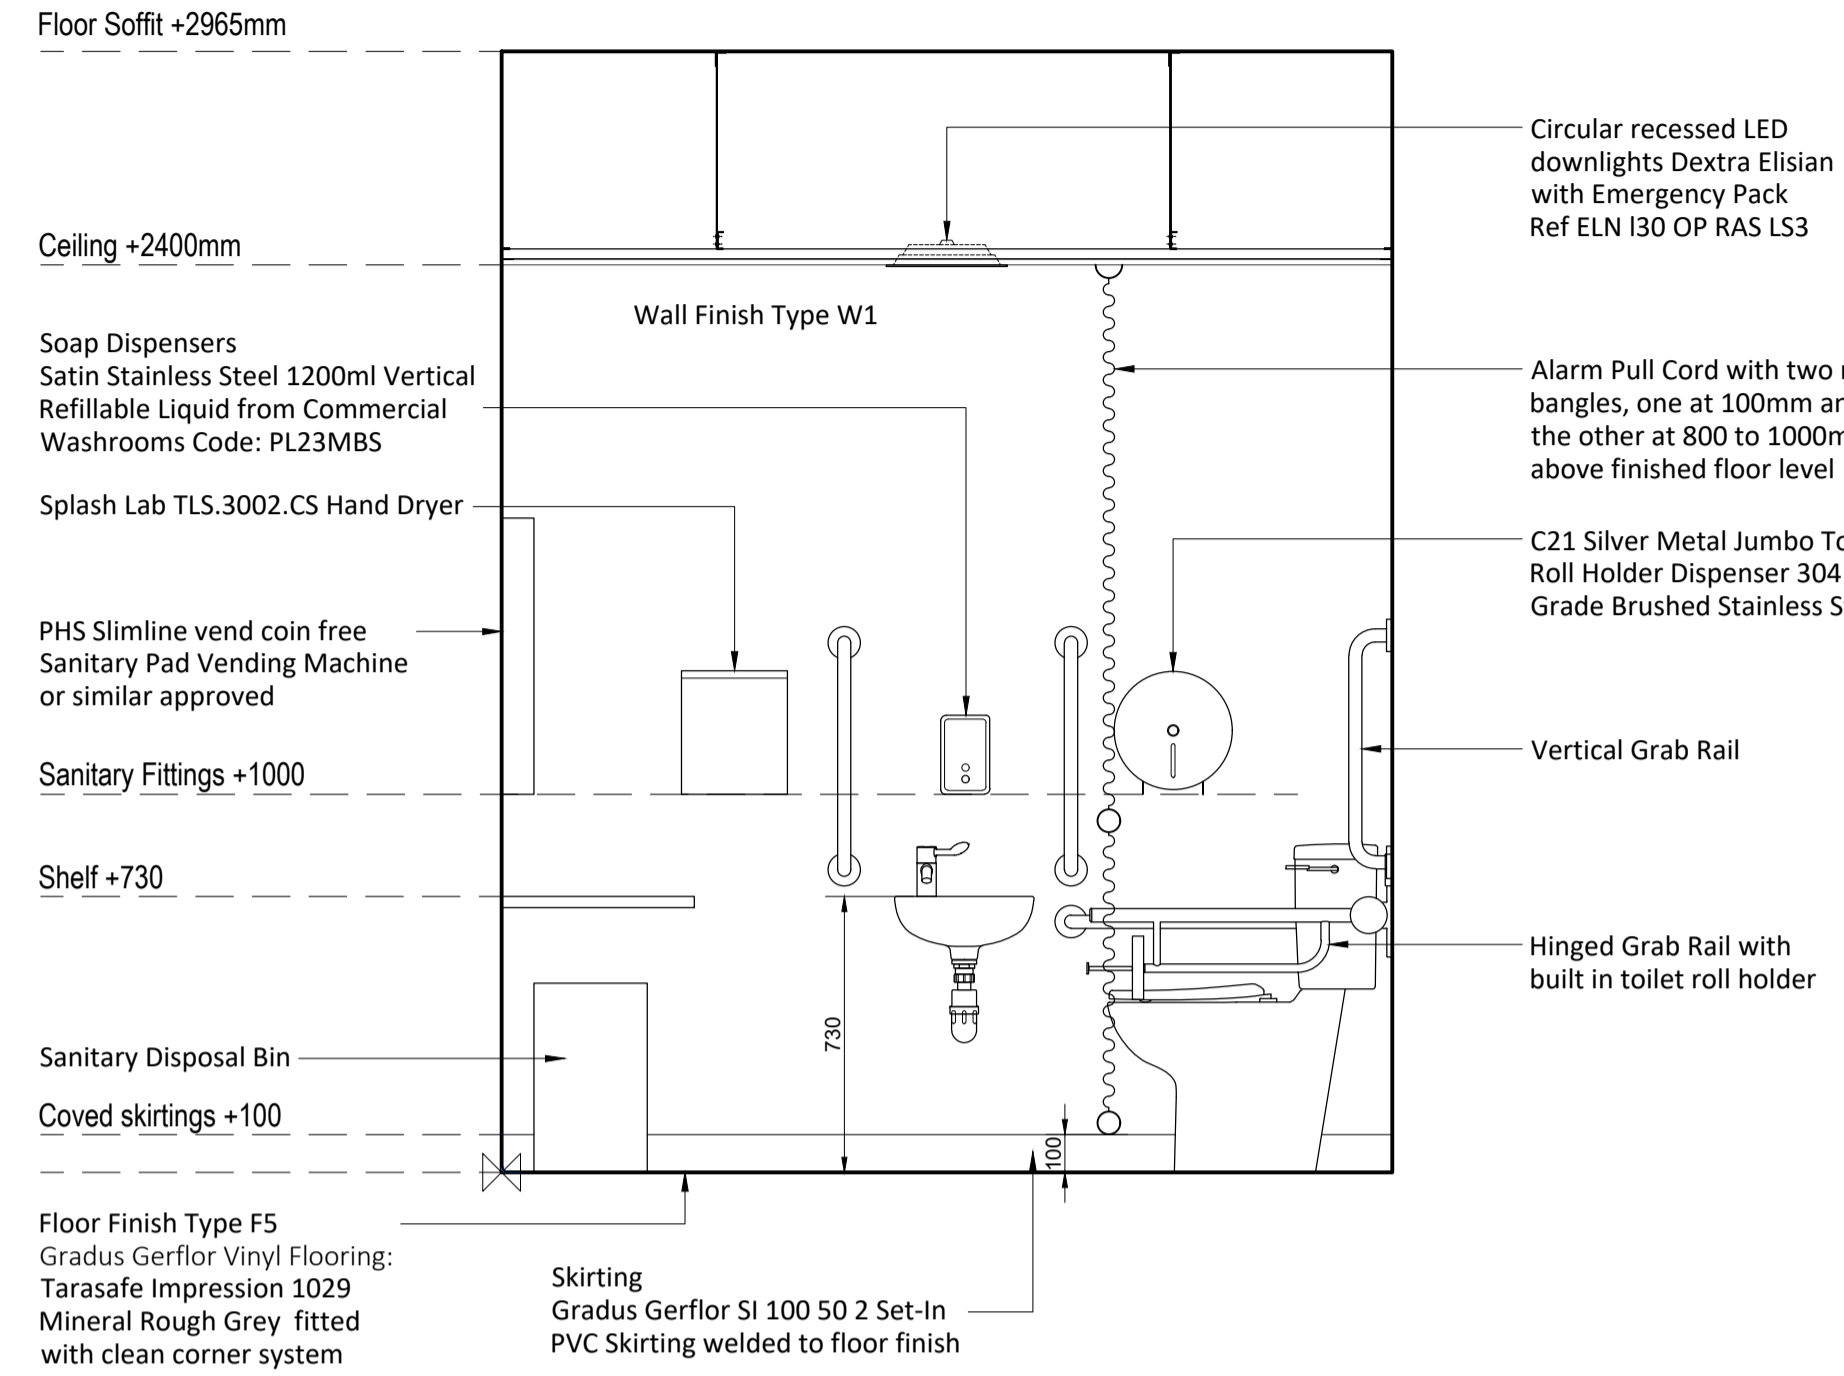

ELEVATION B

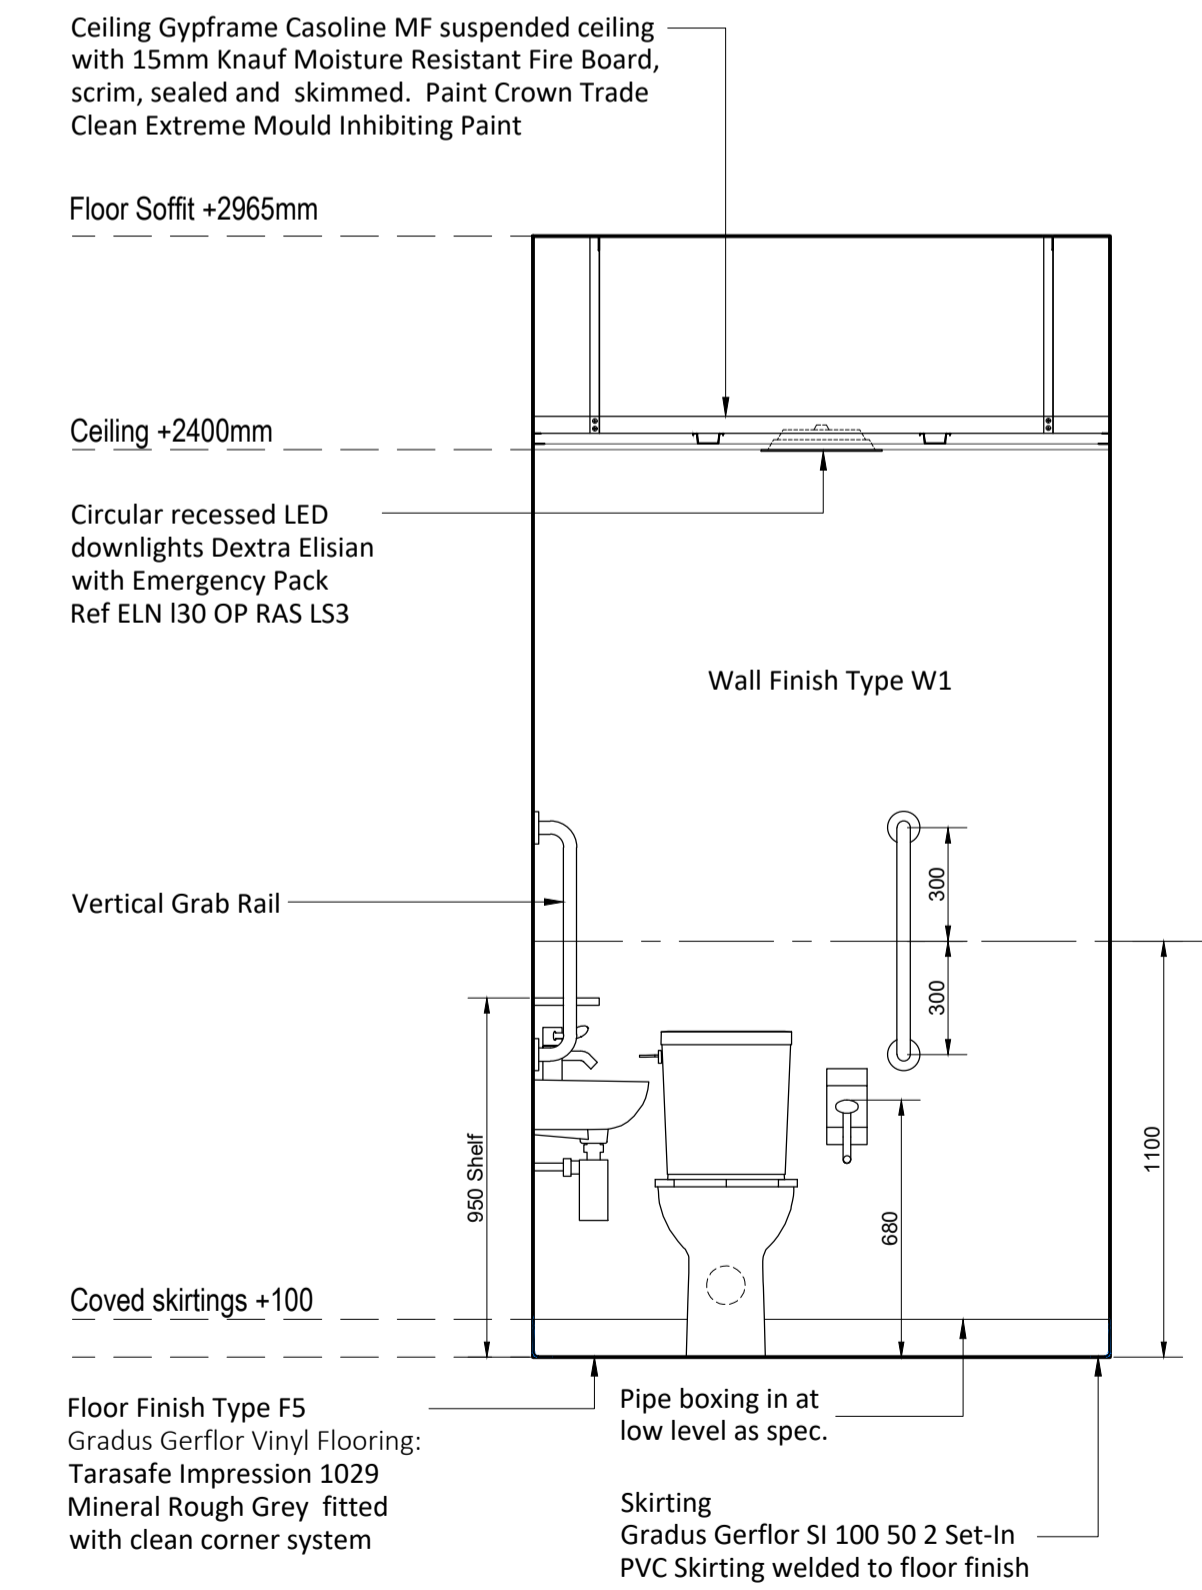

ELEVATION C

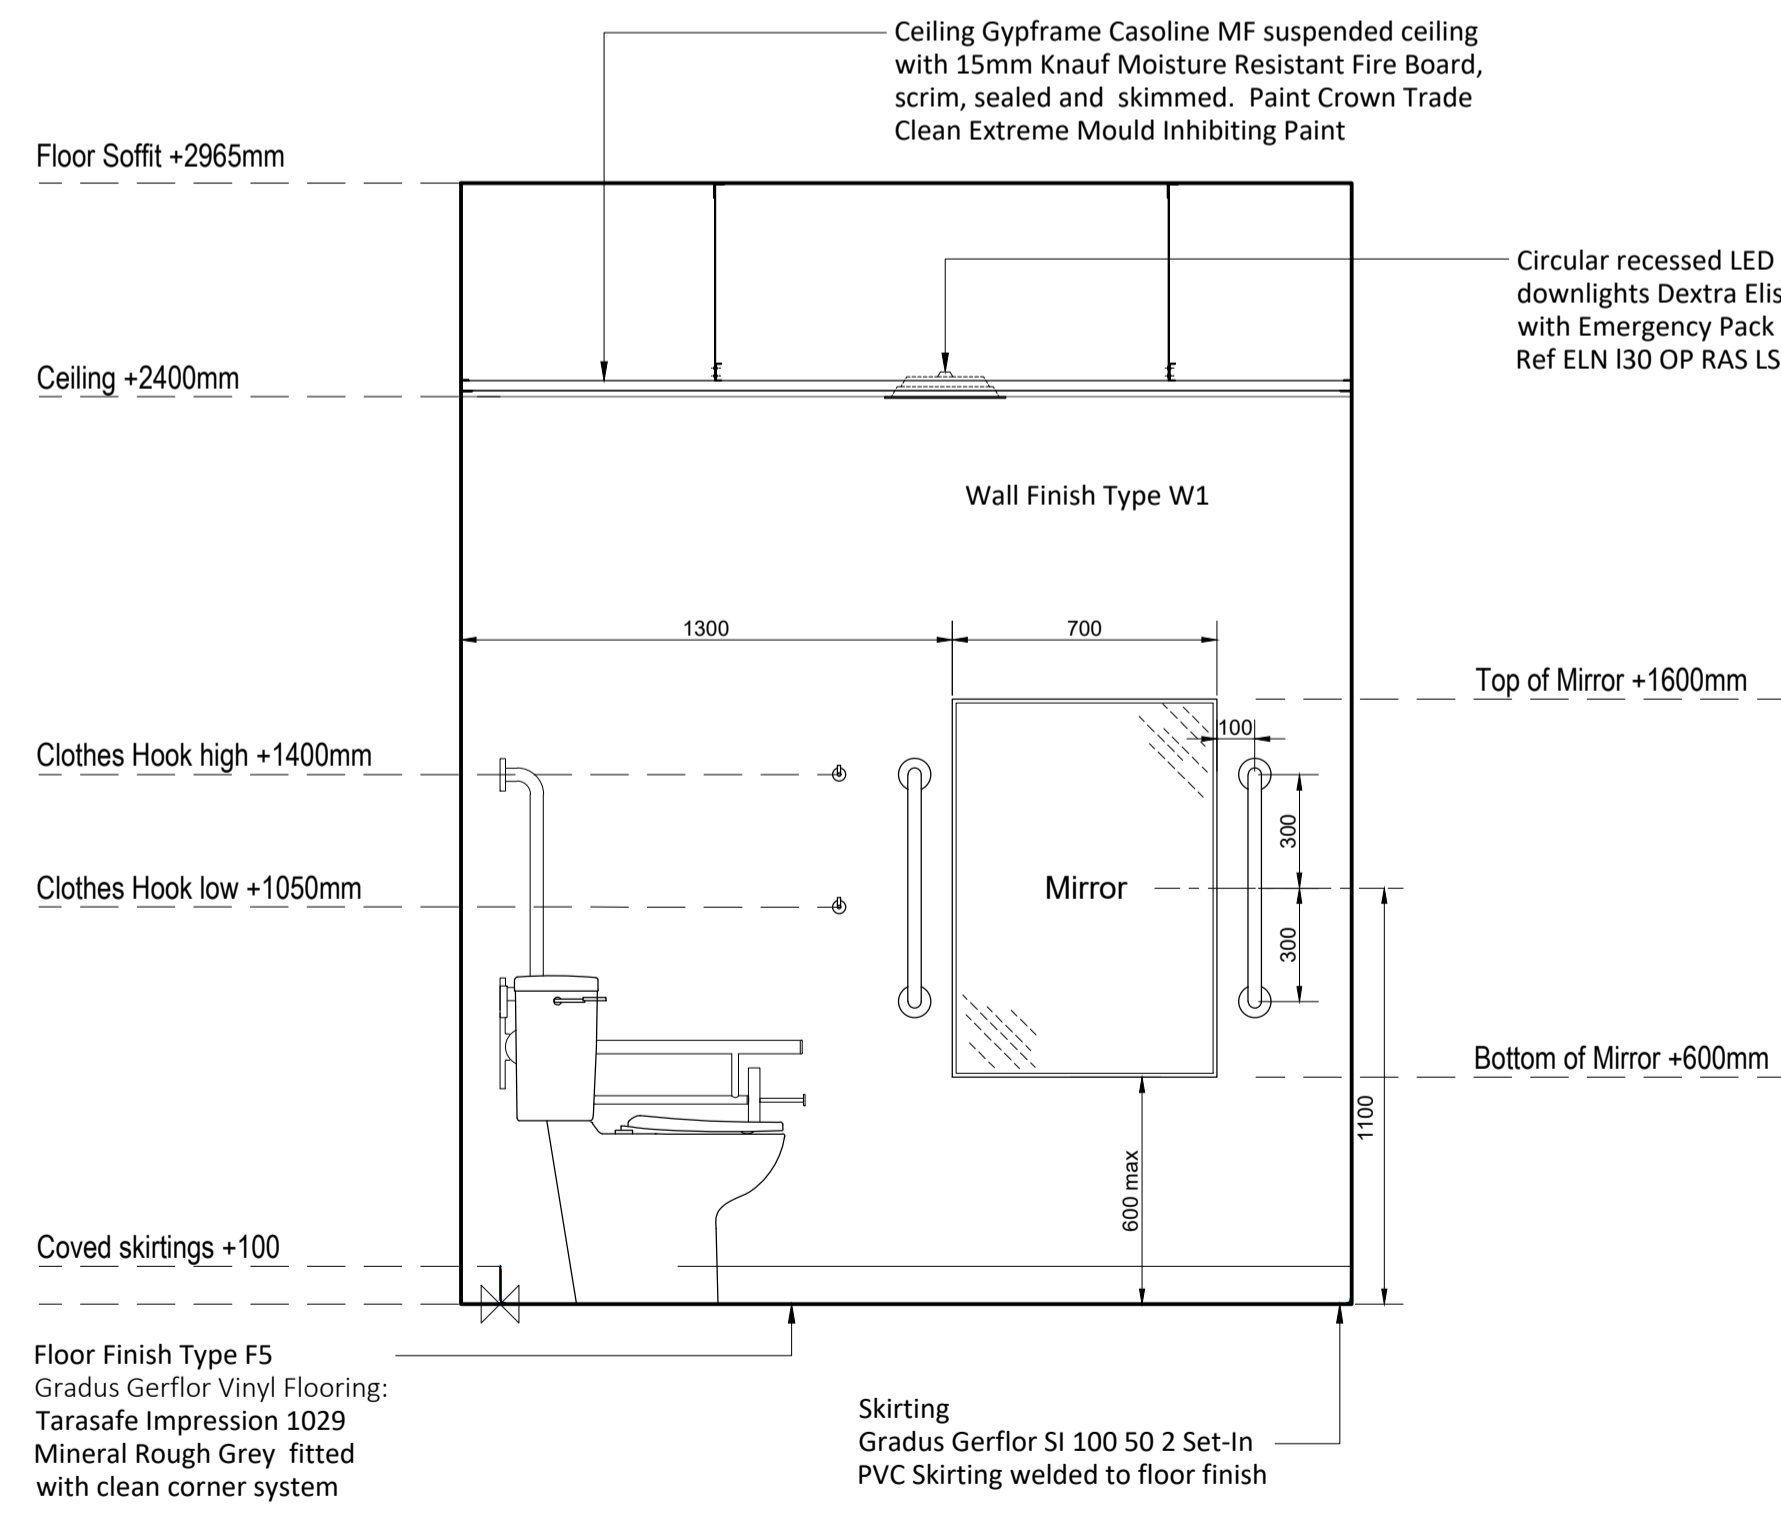

ELEVATION D

Revisions			
No.	Revision	Date	By
-	-	-	-

SPECIFICATIONS

Accessible WC Fittings

Doc M Pack Accessible WC
Armitage Shanks Monaco Doc M Pack - White
Product Code: S7075AC

Includes:

- 1 x Raised height close coupled toilet pack with China cistern
- 1 x 450mm Straight white grab rail
- 4 x 600mm Straight white grab rail
- 1 x Hinged white grab rail
- 1 x Seat included with retaining buffers (no cover)
- 1 x Elongated cistern to achieve 75cm projection
- 1 x Single lever basin mixer tap - chrome

Mirror:
Bobrick Stainless Steel Framed Mirrors with 430 Polished Stainless Steel frame, corrosion-resistant and robust. Mirror Size 700 x 1000mm.

Hand Dryers:
The Splash Lab TSL-3002-CS slim-line high speed hand dryer (or equal approved)

Toilet Roll Holders:
C21 Jumbo Toilet Roll Dispenser 304 Grade Brushed Stainless Steel

Soap Dispensers:
2no. Satin Stainless Steel 1200ml Vertical Refillable Liquid from Commercial Washrooms Product Code: PL23MBS (or equal approved)

Sanitary Pad Vending Machine:
PHS Slimline vend coin free or similar approved

Bin:
20L Sanitary Disposal Bin max height 600mm

Clothes Hooks:
2no. Hampstead Single Coat Hook - 35 x 25mm Satin Stainless Steel

Individual Satin Steel Clothes Hook
Alarm Pull Cord:
Pull cord with two red bangles, one at 100mm and the other at 800 to 1000mm above finished floor level

Lighting:
Refer to Precision HVAC drawing P26-010-PRE-DR-E-0003 'Ground Floor General and Emergency Lighting Layout'

Type D/e Circular recessed led downlights 2316 lumen C84 version complete with opal diffuser, Reacta air sensor and 3 hour self test emergency pack as Dextra Elisian reference
ELN I30 OP RAS LS3

Boxing in of pipework:
House Martin 90 Degree 150x200mm Trade Pipe Boxing Material Thickness: 8mm
Dimensions: 200mm H, 150mm Projection
Fixed to 25x38mm timber battens.
Product Code: A1M1520W8 (Or similar approved)

Finishes
Floor Finish Type F5:
Gradus Gerflor Vinyl Flooring:
Tarasafe Impression 1029 Mineral Rough Grey fitted with clean corner system

Skirting:
Gradus Gerflor SI 100 50 2 Set-In PVC Skirting welded to floor finish

Wall Finish Type W1:
High performance, moisture resistant, easily cleaned wall paint to be colour matched to Farrow and Ball - No. W9 Ash Grey

Ceiling:
Crown Trade Clean Extreme Mould Inhibiting Paint or equal approved



RIBA Chartered Architects & Surveyors
01625 509187
Suite 20, Beechfield House, Macclesfield, Cheshire SK11 0LP

Project Title
South Park Pavilion, Macclesfield

Element
ROOM DATA SHEET

Drawing Title
Room G17 - Unisex Accessible WC

Status	Scale	Date	Drawn By	Checked
Construction	1:20 @ A1	April 26	MY	-
Job No.	Category	CISB Element	Sequential No.	Revision
23346	S	(4-)	09	-