




Revisions			
No.	Revision	Date	By
-	-	-	-

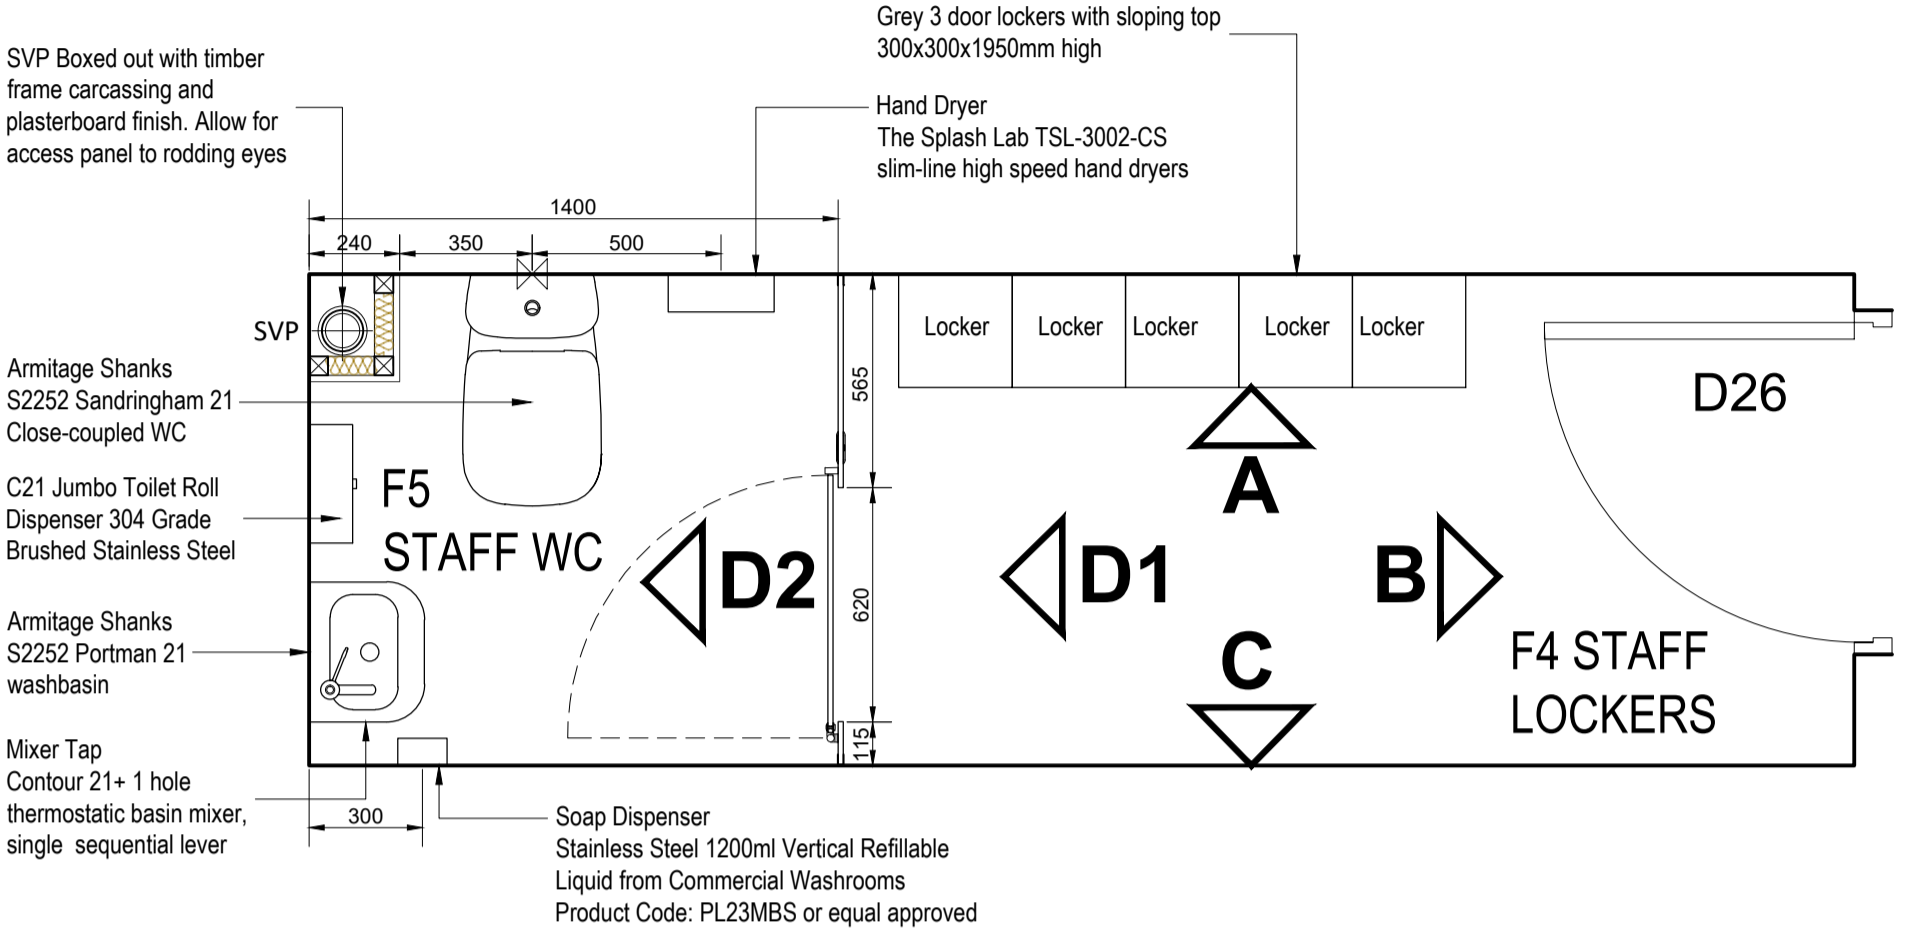

F4/F5 EVENT KITCHEN STAFF FACILITIES

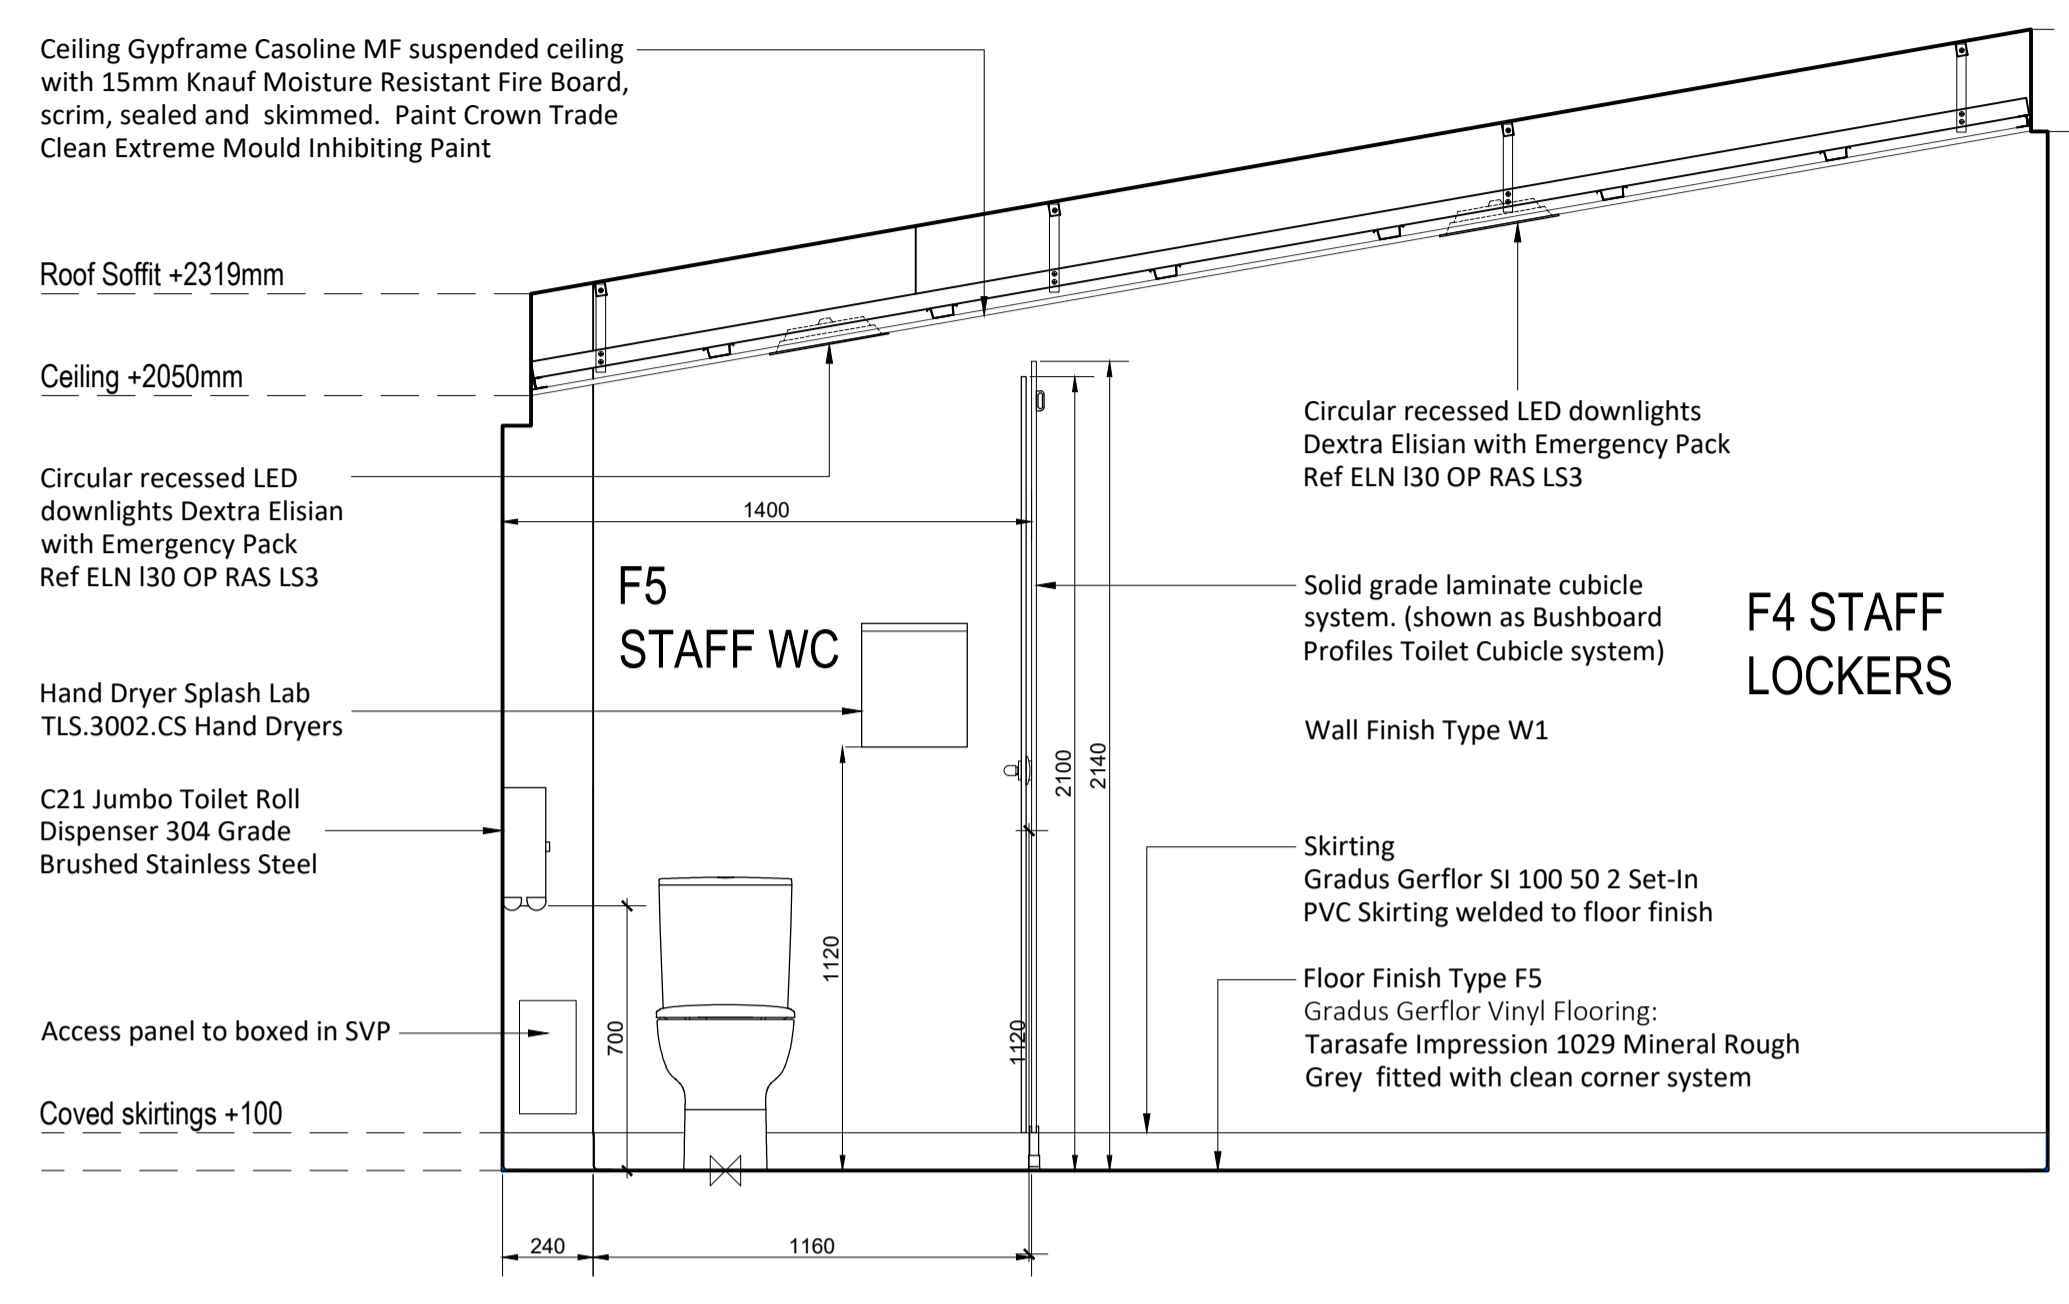

ELEVATION A

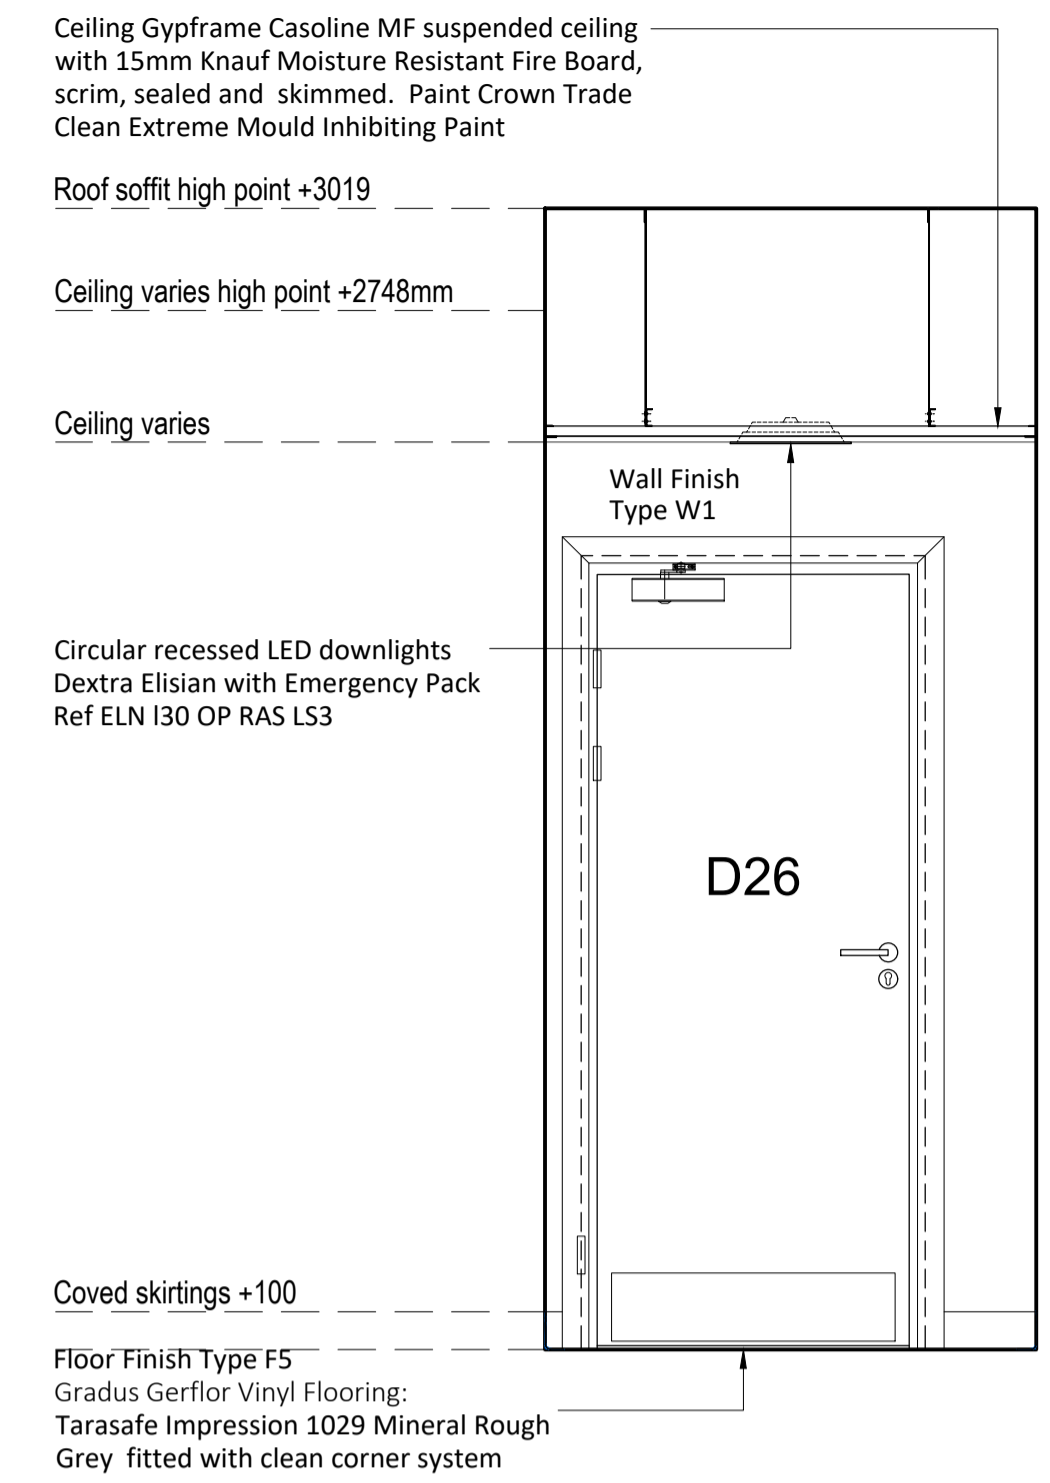

ELEVATION B

SPECIFICATIONS

Washroom Fittings

Toilet:
Armitage Shanks Sandringham 21 Close-coupled open bowl bundle.

Includes:

- E896301: Sandringham 21 Close-coupled open bowl
- E131601: Multi suites - Finished Products Sandwich seat
- E896601: Sandringham 21 Toilet cistern

Toilet Cubicles:
Solid Grade Laminate (SGL) Toilet Cubicals:
Bush Board Profiles Toilet Cubicle system (or equal approved)

Wash Hand Basins:
Armitage Shanks S2252 Portman 21 washbasin 50cm, 1 taphole.

Taps:
Contour 21+ 1 hole thermostatic basin mixer, single sequential lever with copper tails (or equal approved)

Mirrors:
Bobrick Stainless Steel Framed Mirrors with 430 Polished Stainless Steel frame, corrosion-resistant and robust. Mirror Size 460 x 910mm

Hand Dryer:
The Splash Lab TSL-3002-CS slim-line high speed hand dryer (or equal approved)

Toilet Roll Holder:
C21 Jumbo Toilet Roll Dispenser 304 Grade Brushed Stainless Steel

Soap Dispensers:
2no. Satin Stainless Steel 1200ml Vertical Refillable Liquid from Commercial Washrooms Product Code: PL23MBS (or equal approved)

Bin:
Brabantia 60L Touch Bin - Brilliant Steel With Black Lid

Lighting:
Refer to Precision HVAC drawing P26-010-PRE-DR-E-0003 'Ground Floor General and Emergency Lighting Layout'

Type D/e (2no.) Circular recessed led downlights 2316 lumen C84 version complete with opal diffuser, Reacta air sensor and 3 hour self test emergency pack as Dextra Elisian reference ELN I30 OP RAS LS3


Finishes

Floor Finish Type F5:
Gradus Gerflor Vinyl Flooring:
Tarasafe Impression 1029 Mineral Rough Grey fitted with clean corner system


Skirting:
Gradus Gerflor SI 100 50 2 Set-In PVC Skirting welded to floor finish

Wall Finish Type W1:
High performance, moisture resistant, easily cleaned wall paint to be colour matched to Farrow and Ball - No. W9 Ash Grey


Ceiling:
Crown Trade Clean Extreme Mould Inhibiting Paint or equal approved

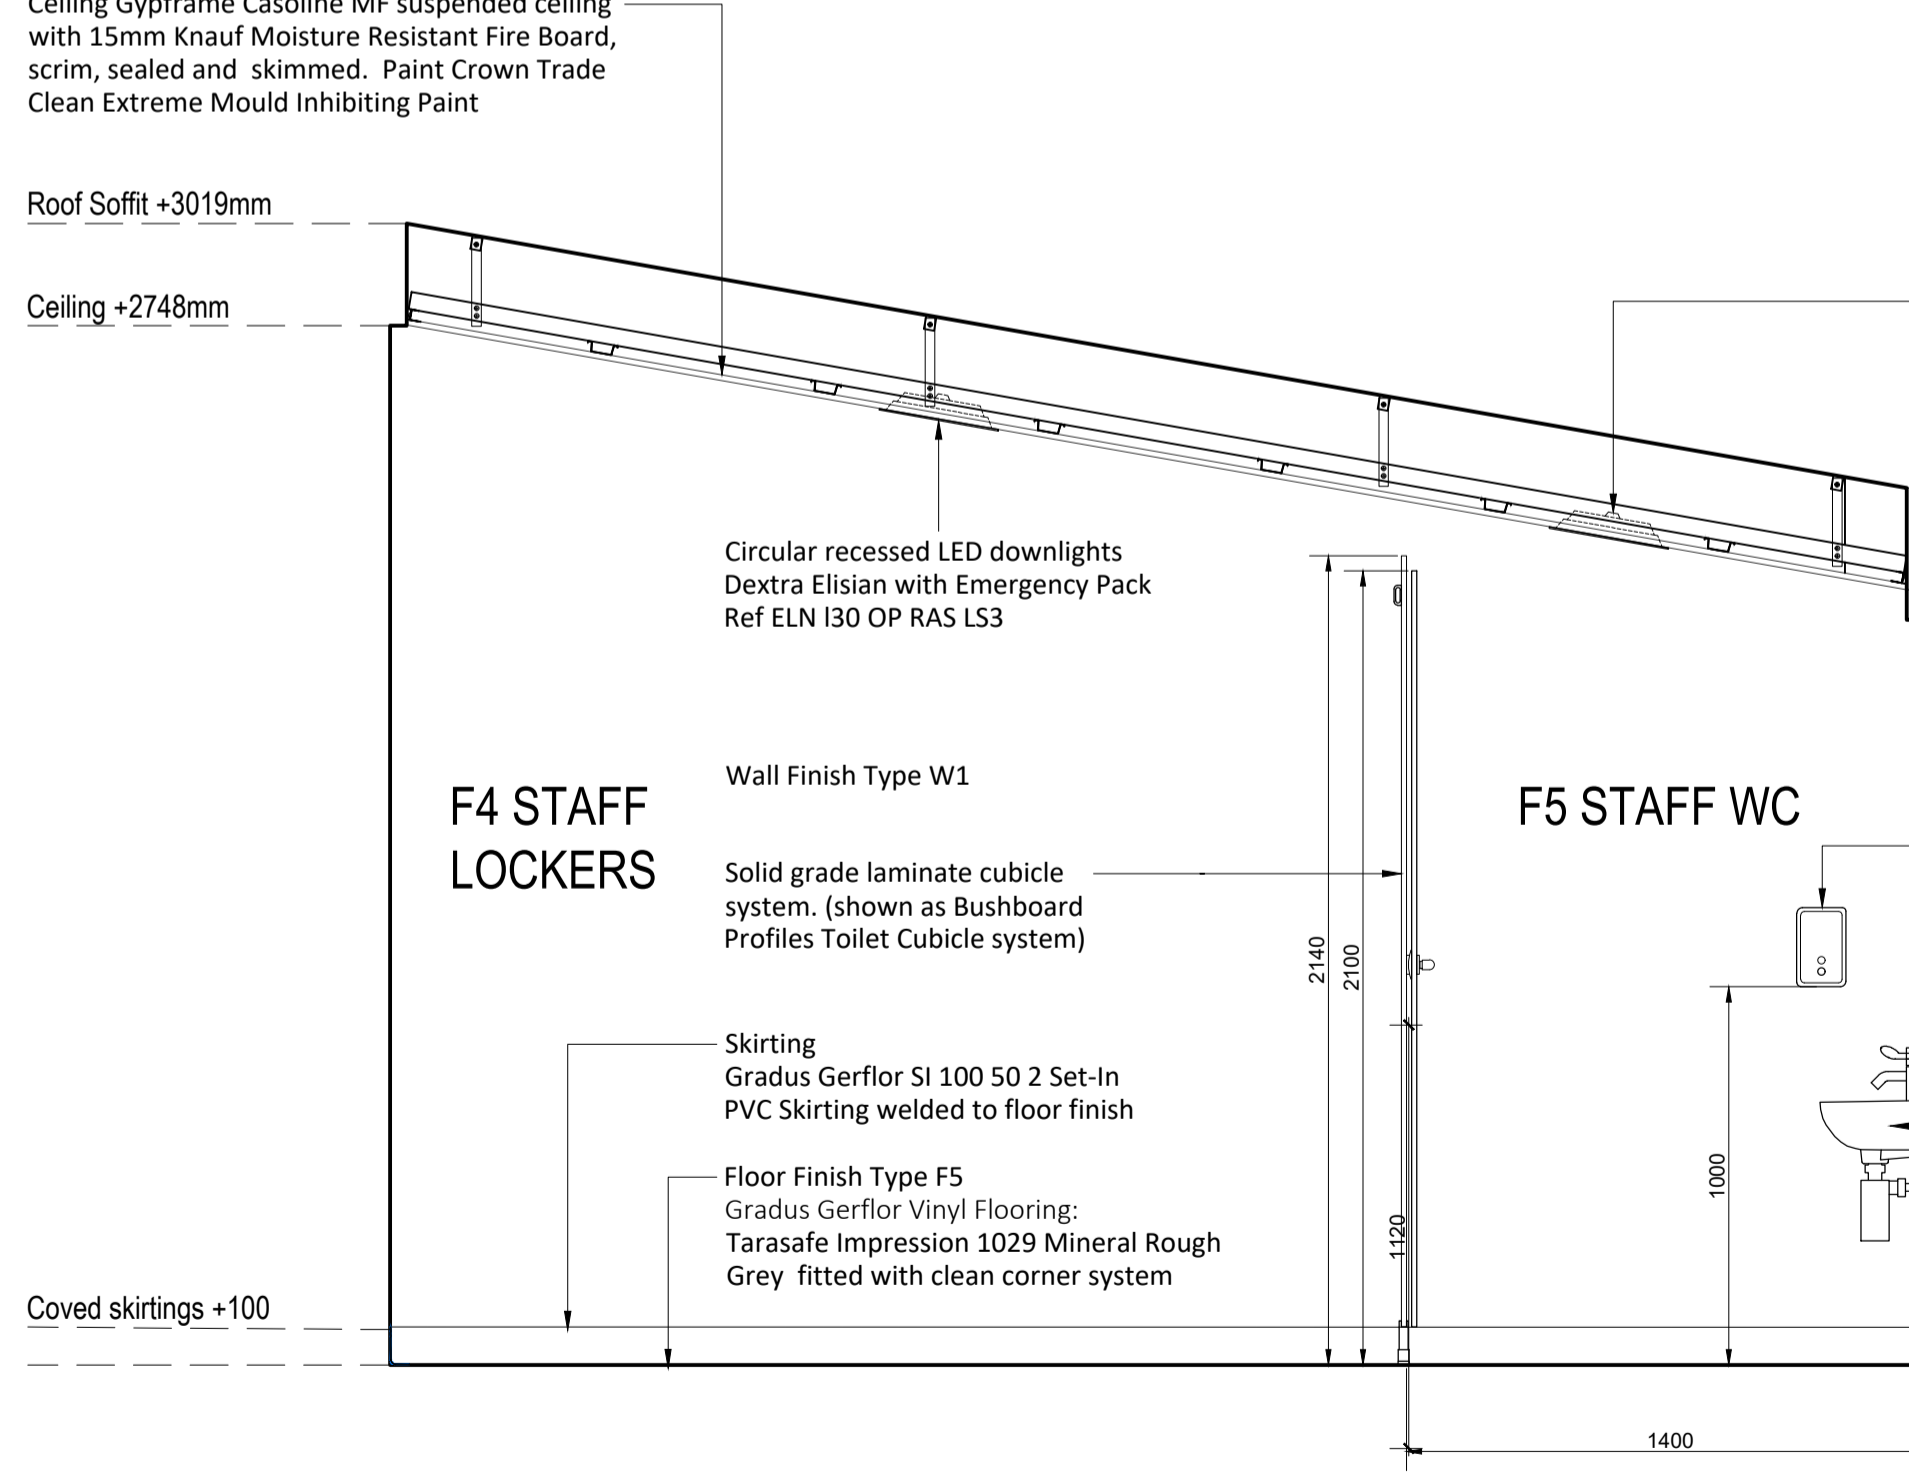

ELEVATION C

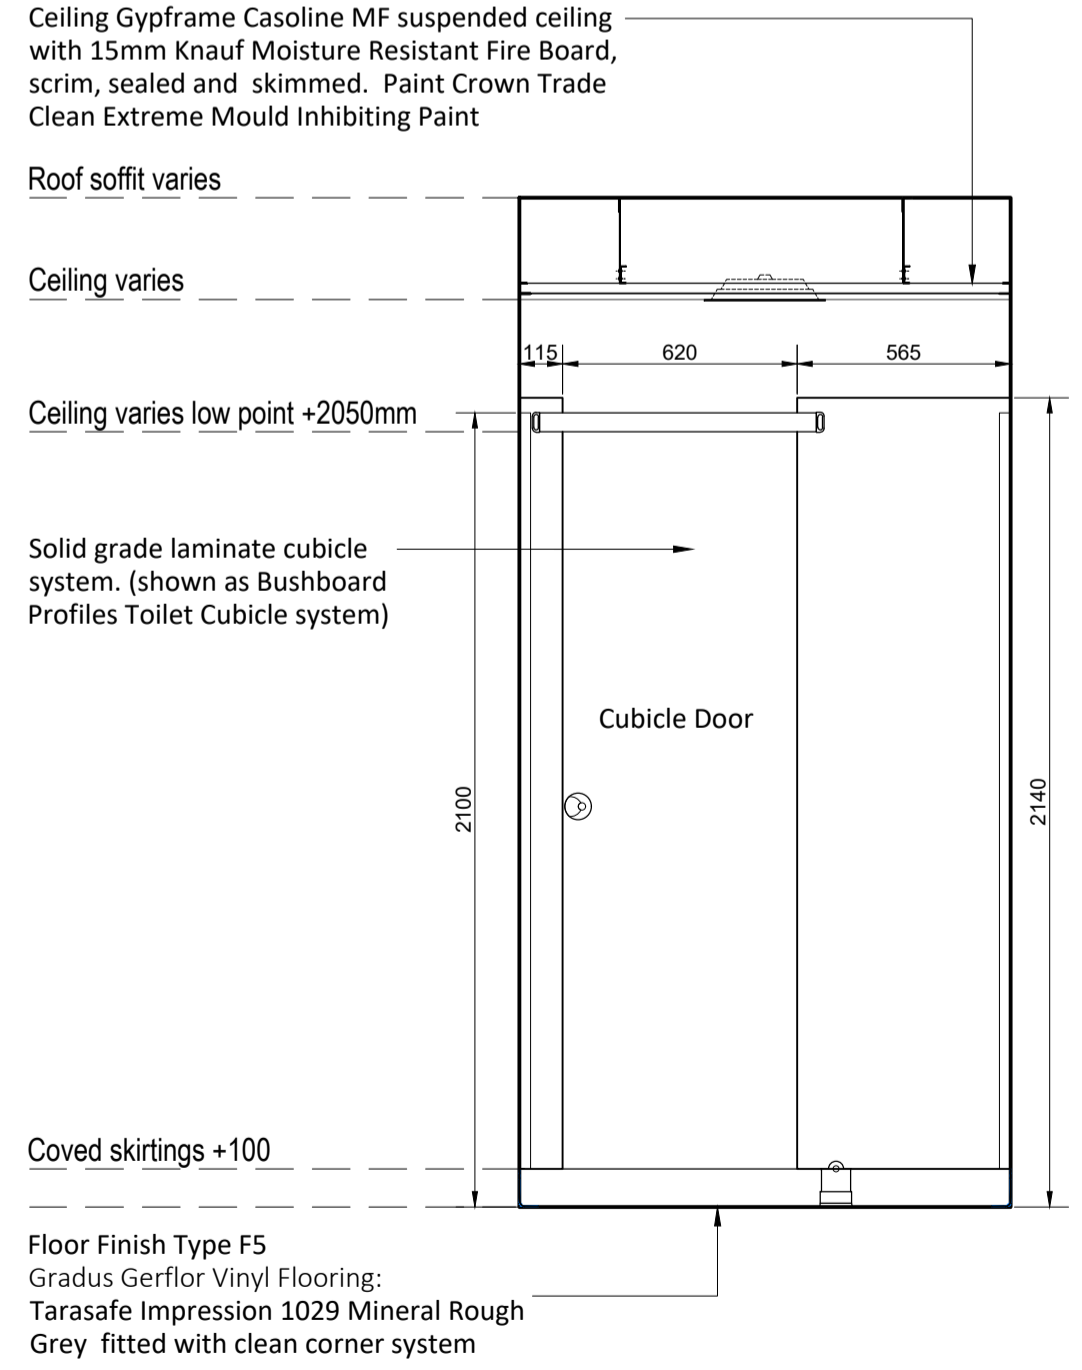

ELEVATION D1

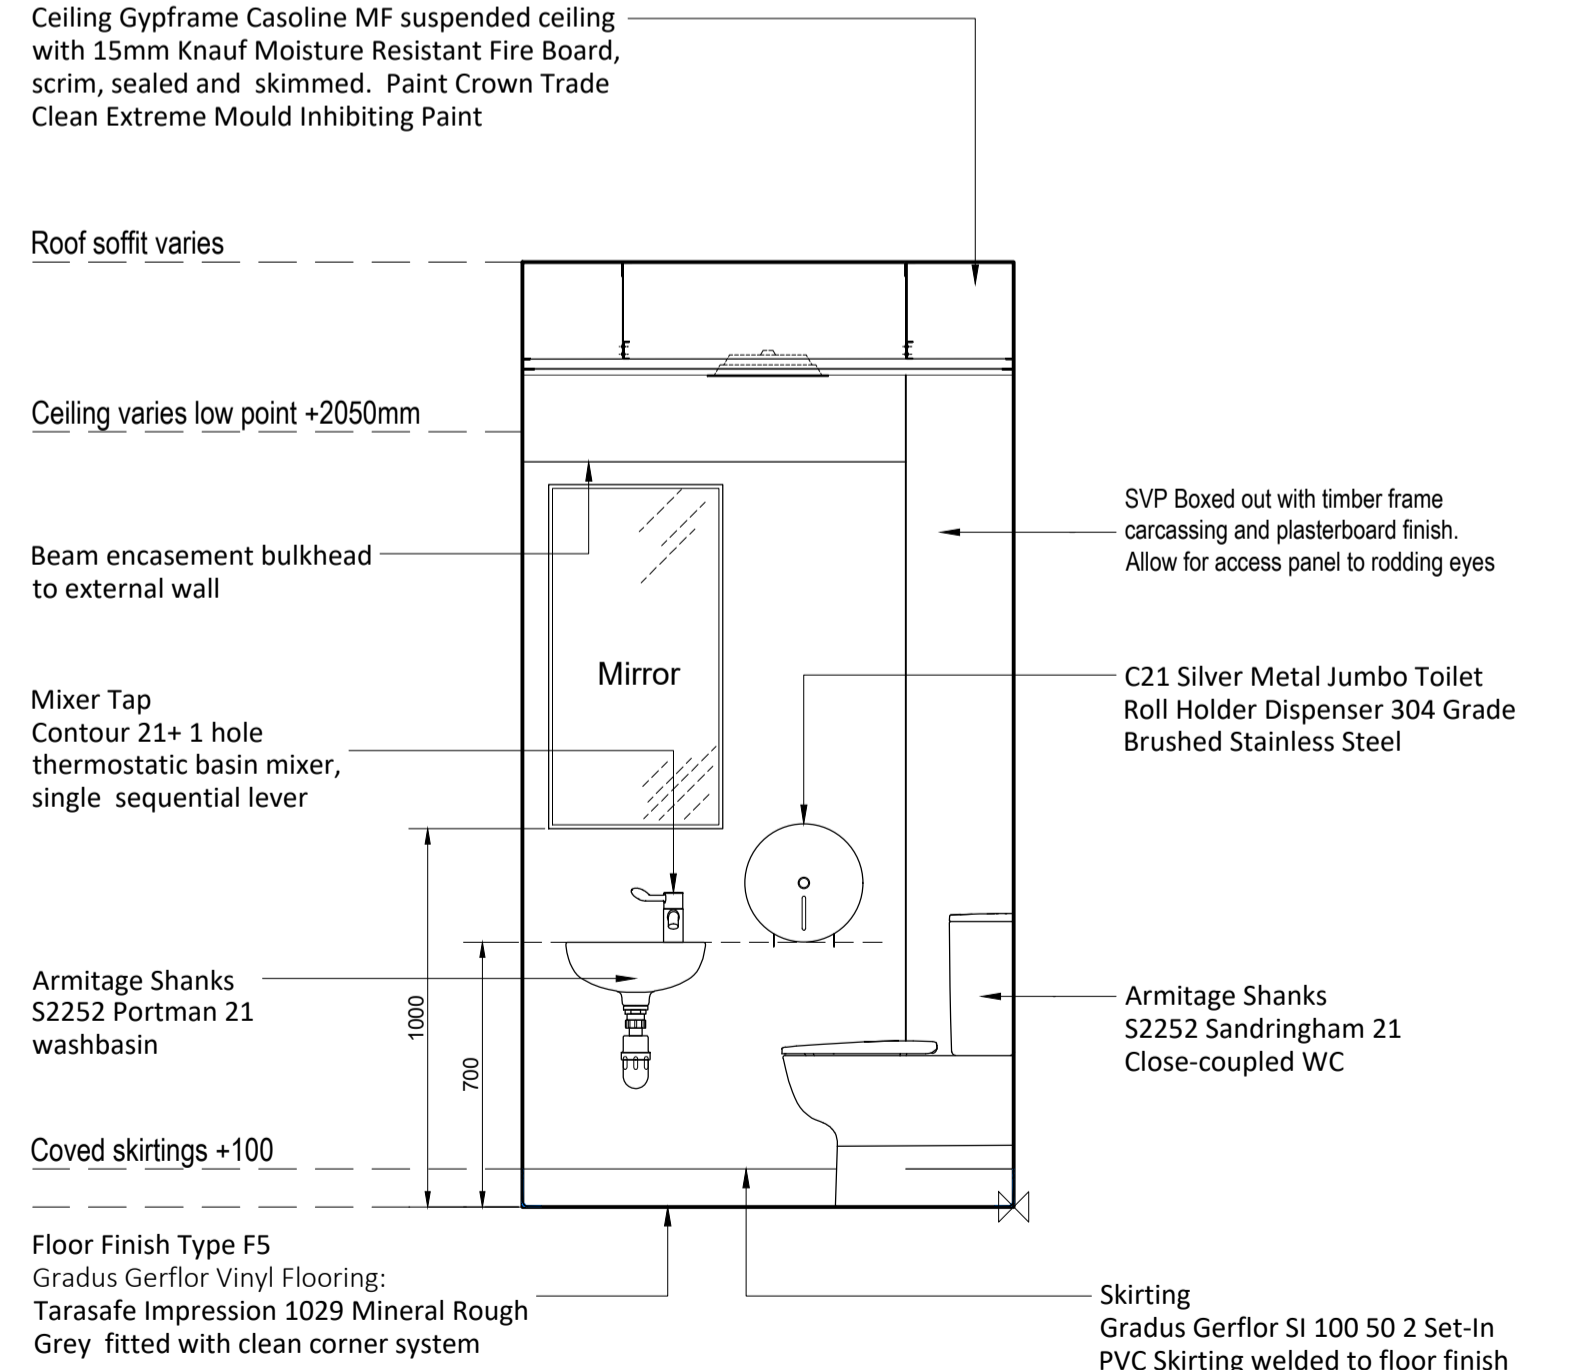

ELEVATION D2



RIBA Chartered Architects & Surveyors
01625 509187
Suite 20, Beechfield House, Macclesfield, Cheshire SK11 0LP

Project Title
South Park Pavilion, Macclesfield

ROOM DATA SHEET

Drawing Title
Rooms F4 & F5 - Events Kitchen Staff

Status	Scale	Date	Drawn By	Checked
Construction	1:20 @ A1	April 26	MY	-
Job No.	Category	CISb Element	Sequential No.	Revision
23346	S	(4-)	10	-